


ZONE	REV	DESCRIPTION	DATE	REV
LTR	B	ENCLOSURE MATCHES MINI PBU	13-JUN-2018	AA

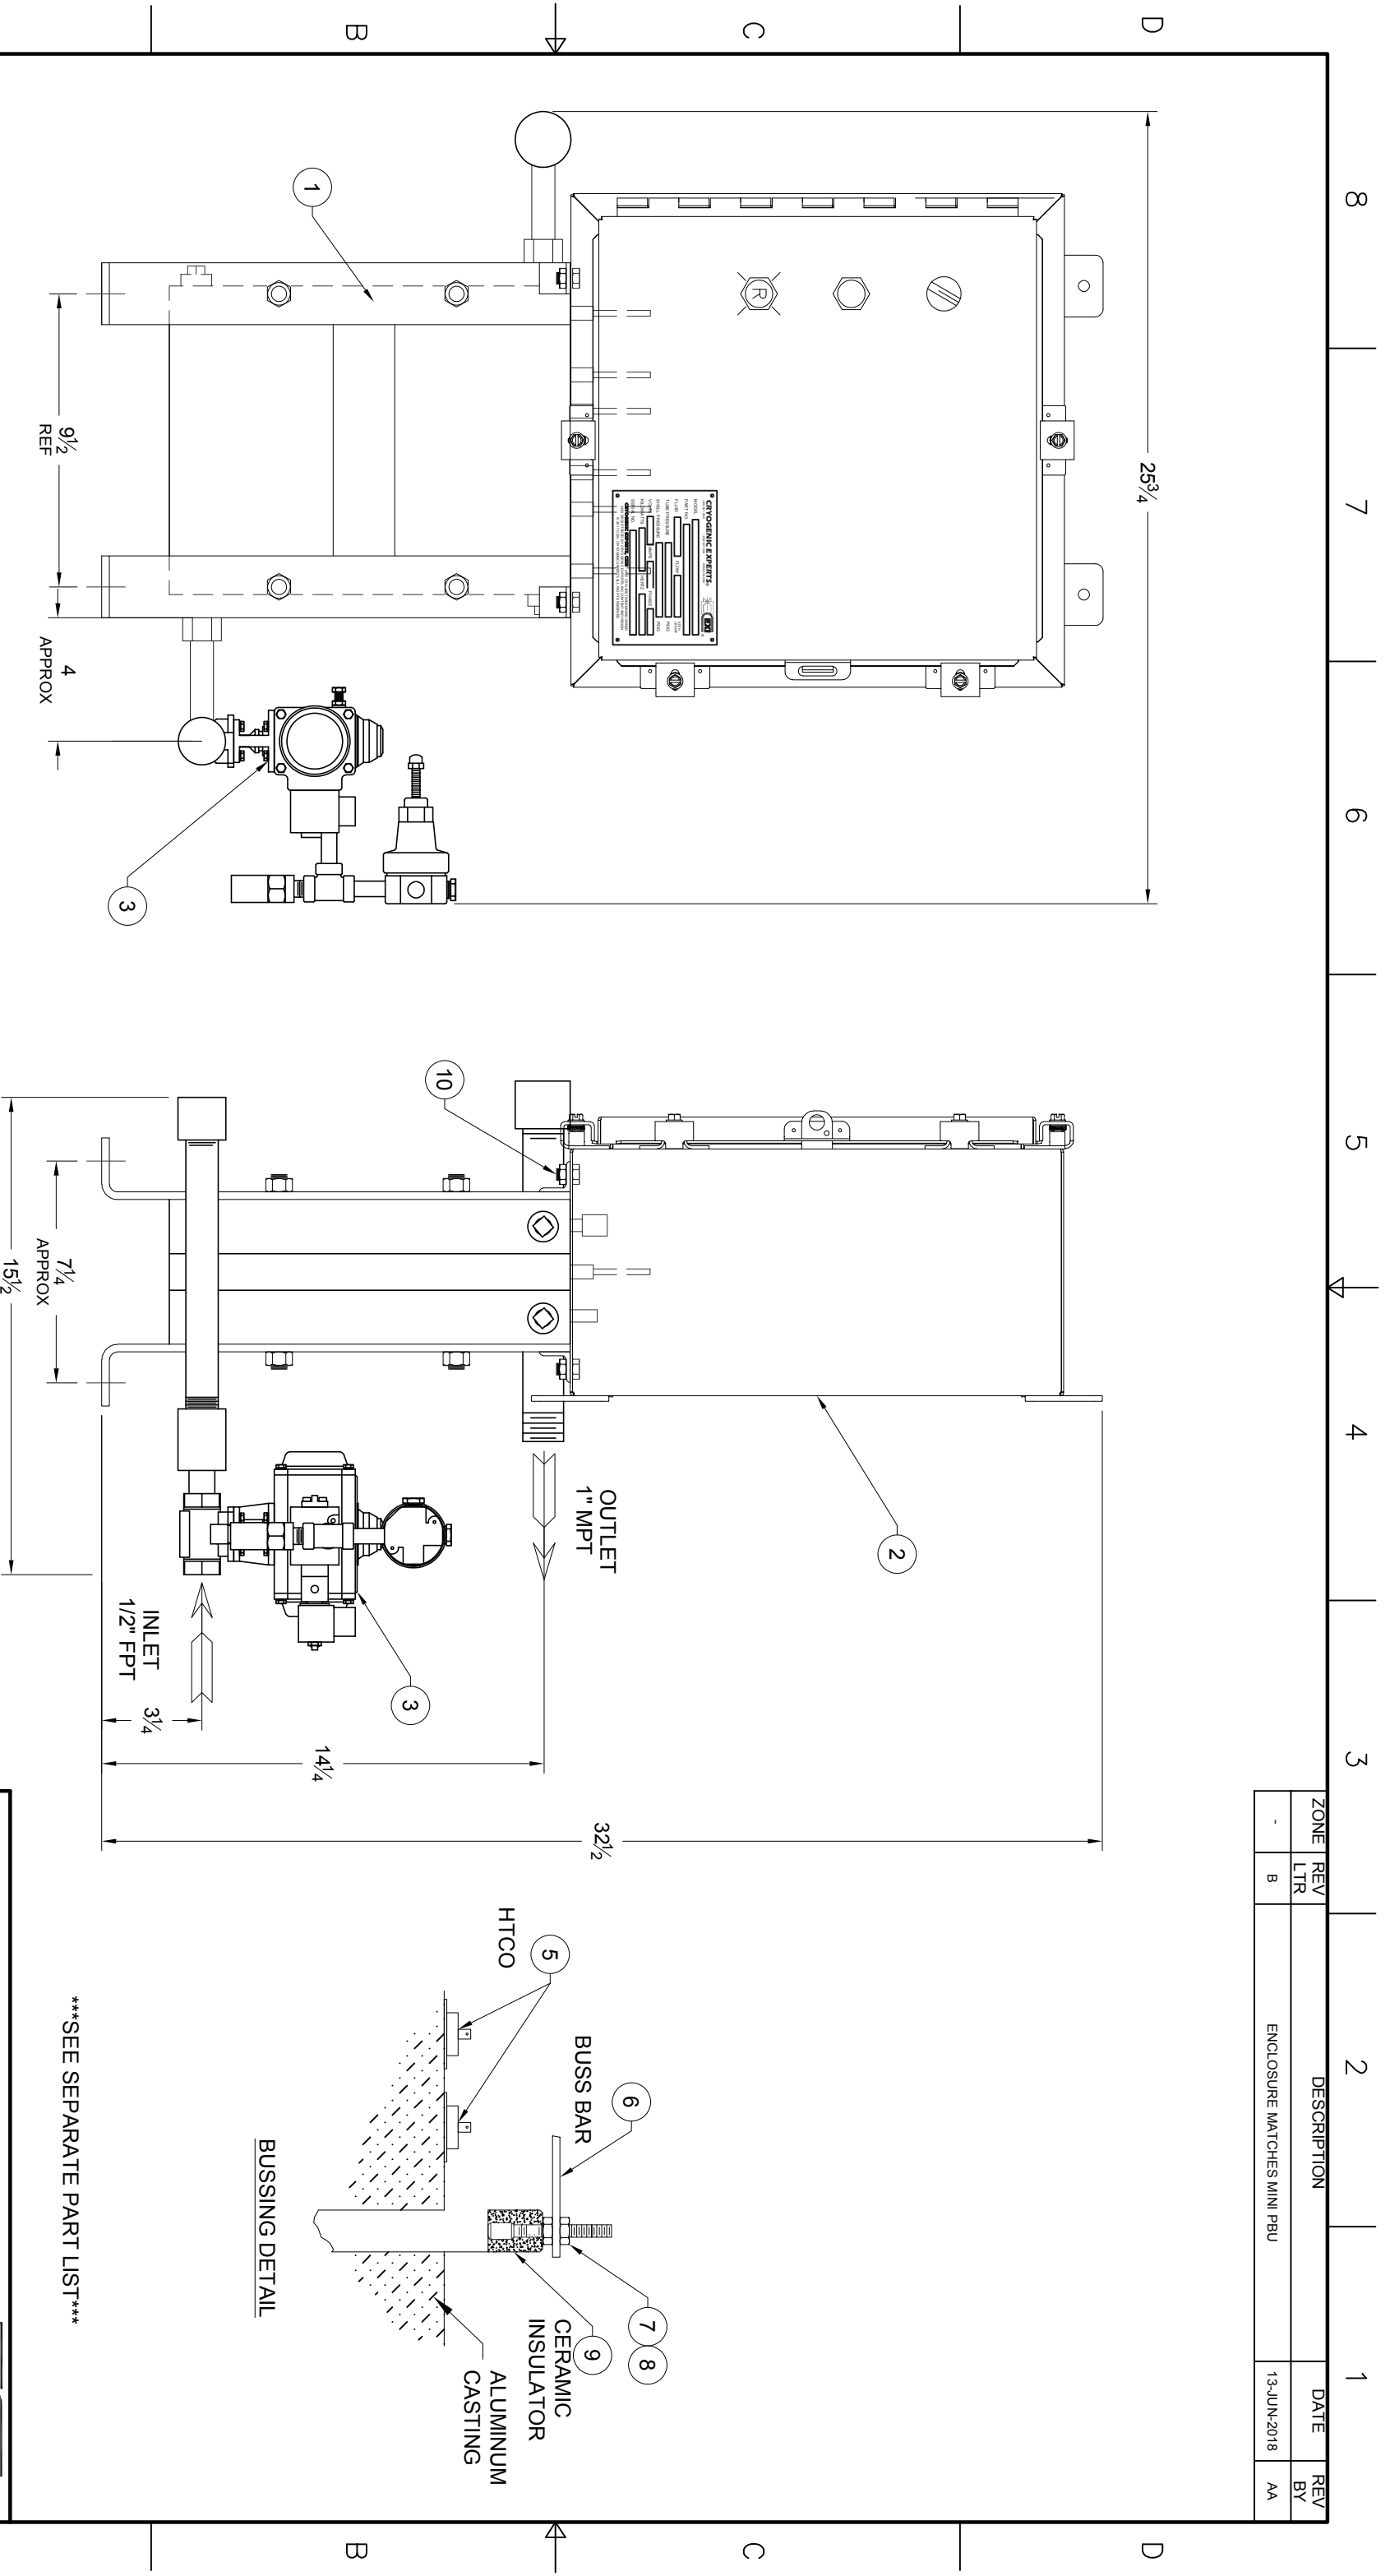

SEE SEPARATE PART LIST

FRONT ELEVATION

RIGHT ELEVATION

CRYOGENIC EXPERTS
 (805)981-4500
 (800)367-2394
 WWW.CEIX.COM

EXI

**ELECTRIC PRESSURE BUILD UNIT
 GENERAL ASSEMBLY**

APPROVALS: DRAWN: JZ DATE: 21-NOV-2017
 CHECKED: ISSUED: USED ON SIM TO

FILENAME: EP-0B0A-12043-000

SIZE: B
 FRGM NO.: 55429
 DWG. NO.: EP-1D0A-15043-000
 SCALE: 1:5

JOB NUMBER: 180615 SHEET 1 OF 1

PROPRIETARY AND CONFIDENTIAL
 THE INFORMATION CONTAINED IN THIS DRAWING IS THE SOLE PROPERTY OF CRYOGENIC EXPERTS, INC. ANY REPRODUCTION IN PART OR AS A WHOLE WITHOUT THE WRITTEN PERMISSION OF CRYOGENIC EXPERTS, INC. IS PROHIBITED.
 © 2017 CEI, CRYOGENIC EXPERTS
 ALL RIGHTS RESERVED

A

B

C

D

8

7

6

5

4

3

2

1

8

7

6

5

4

3

2

1